


FURNITURE, FIXTURE, & EQUIPMENT GENERAL NOTES

- 1. OWNER TO PROVIDE AND INSTALL FURNITURE; FURNITURE SHOWN HALFTONED AND FOR CONTRACTOR REFERENCE
- 2. ALL FURNITURE AND EQUIPMENT TO BE COORDINATED WITH MEP AND A/V CONTRACTOR
- 3. ALL FINAL FURNITURE AND EQUIPMENT LOCATIONS TO BE COORDINATED WITH OWNER PRIOR TO INSTALLATION OF COORDINATING MEP AND A/V CONTRACTOR DEVICES
- 4. PROVIDE AND INSTALL BLOCKING AS REQUIRED FOR OWNER PROVIDED FURNITURE AND EQUIPMENT
- 5. ALL EQUIPMENT NOTED TO BE CONTRACTOR PROVIDED ALSO INDICATES INSTALLATION AND COORDINATION AS REQUIRED.
- 6. AUDIO/VISUAL EQUIPMENT PROVIDED AND INSTALLED BY CONTRACTOR; SEE PROJECT MANUAL

EQUIPMENT SCHEDULE				
KEY NOTE	TYPE	MANUFACTURER	MODEL	COMMENTS
1	DISHWASHER			PROVIDED AND INSTALLED BY CONTRACTOR
2	MICROWAVE			PROVIDED AND INSTALLED BY CONTRACTOR
3	FREESTANDING RANGE			PROVIDED AND INSTALLED BY CONTRACTOR; NO HOOKUPS, APPLIANCE ONLY
4	REFRIGERATOR			PROVIDED AND INSTALLED BY CONTRACTOR
5	WASHER			NOT IN CONTRACT; SEE MEP
6	DRYER			NOT IN CONTRACT; SEE MEP

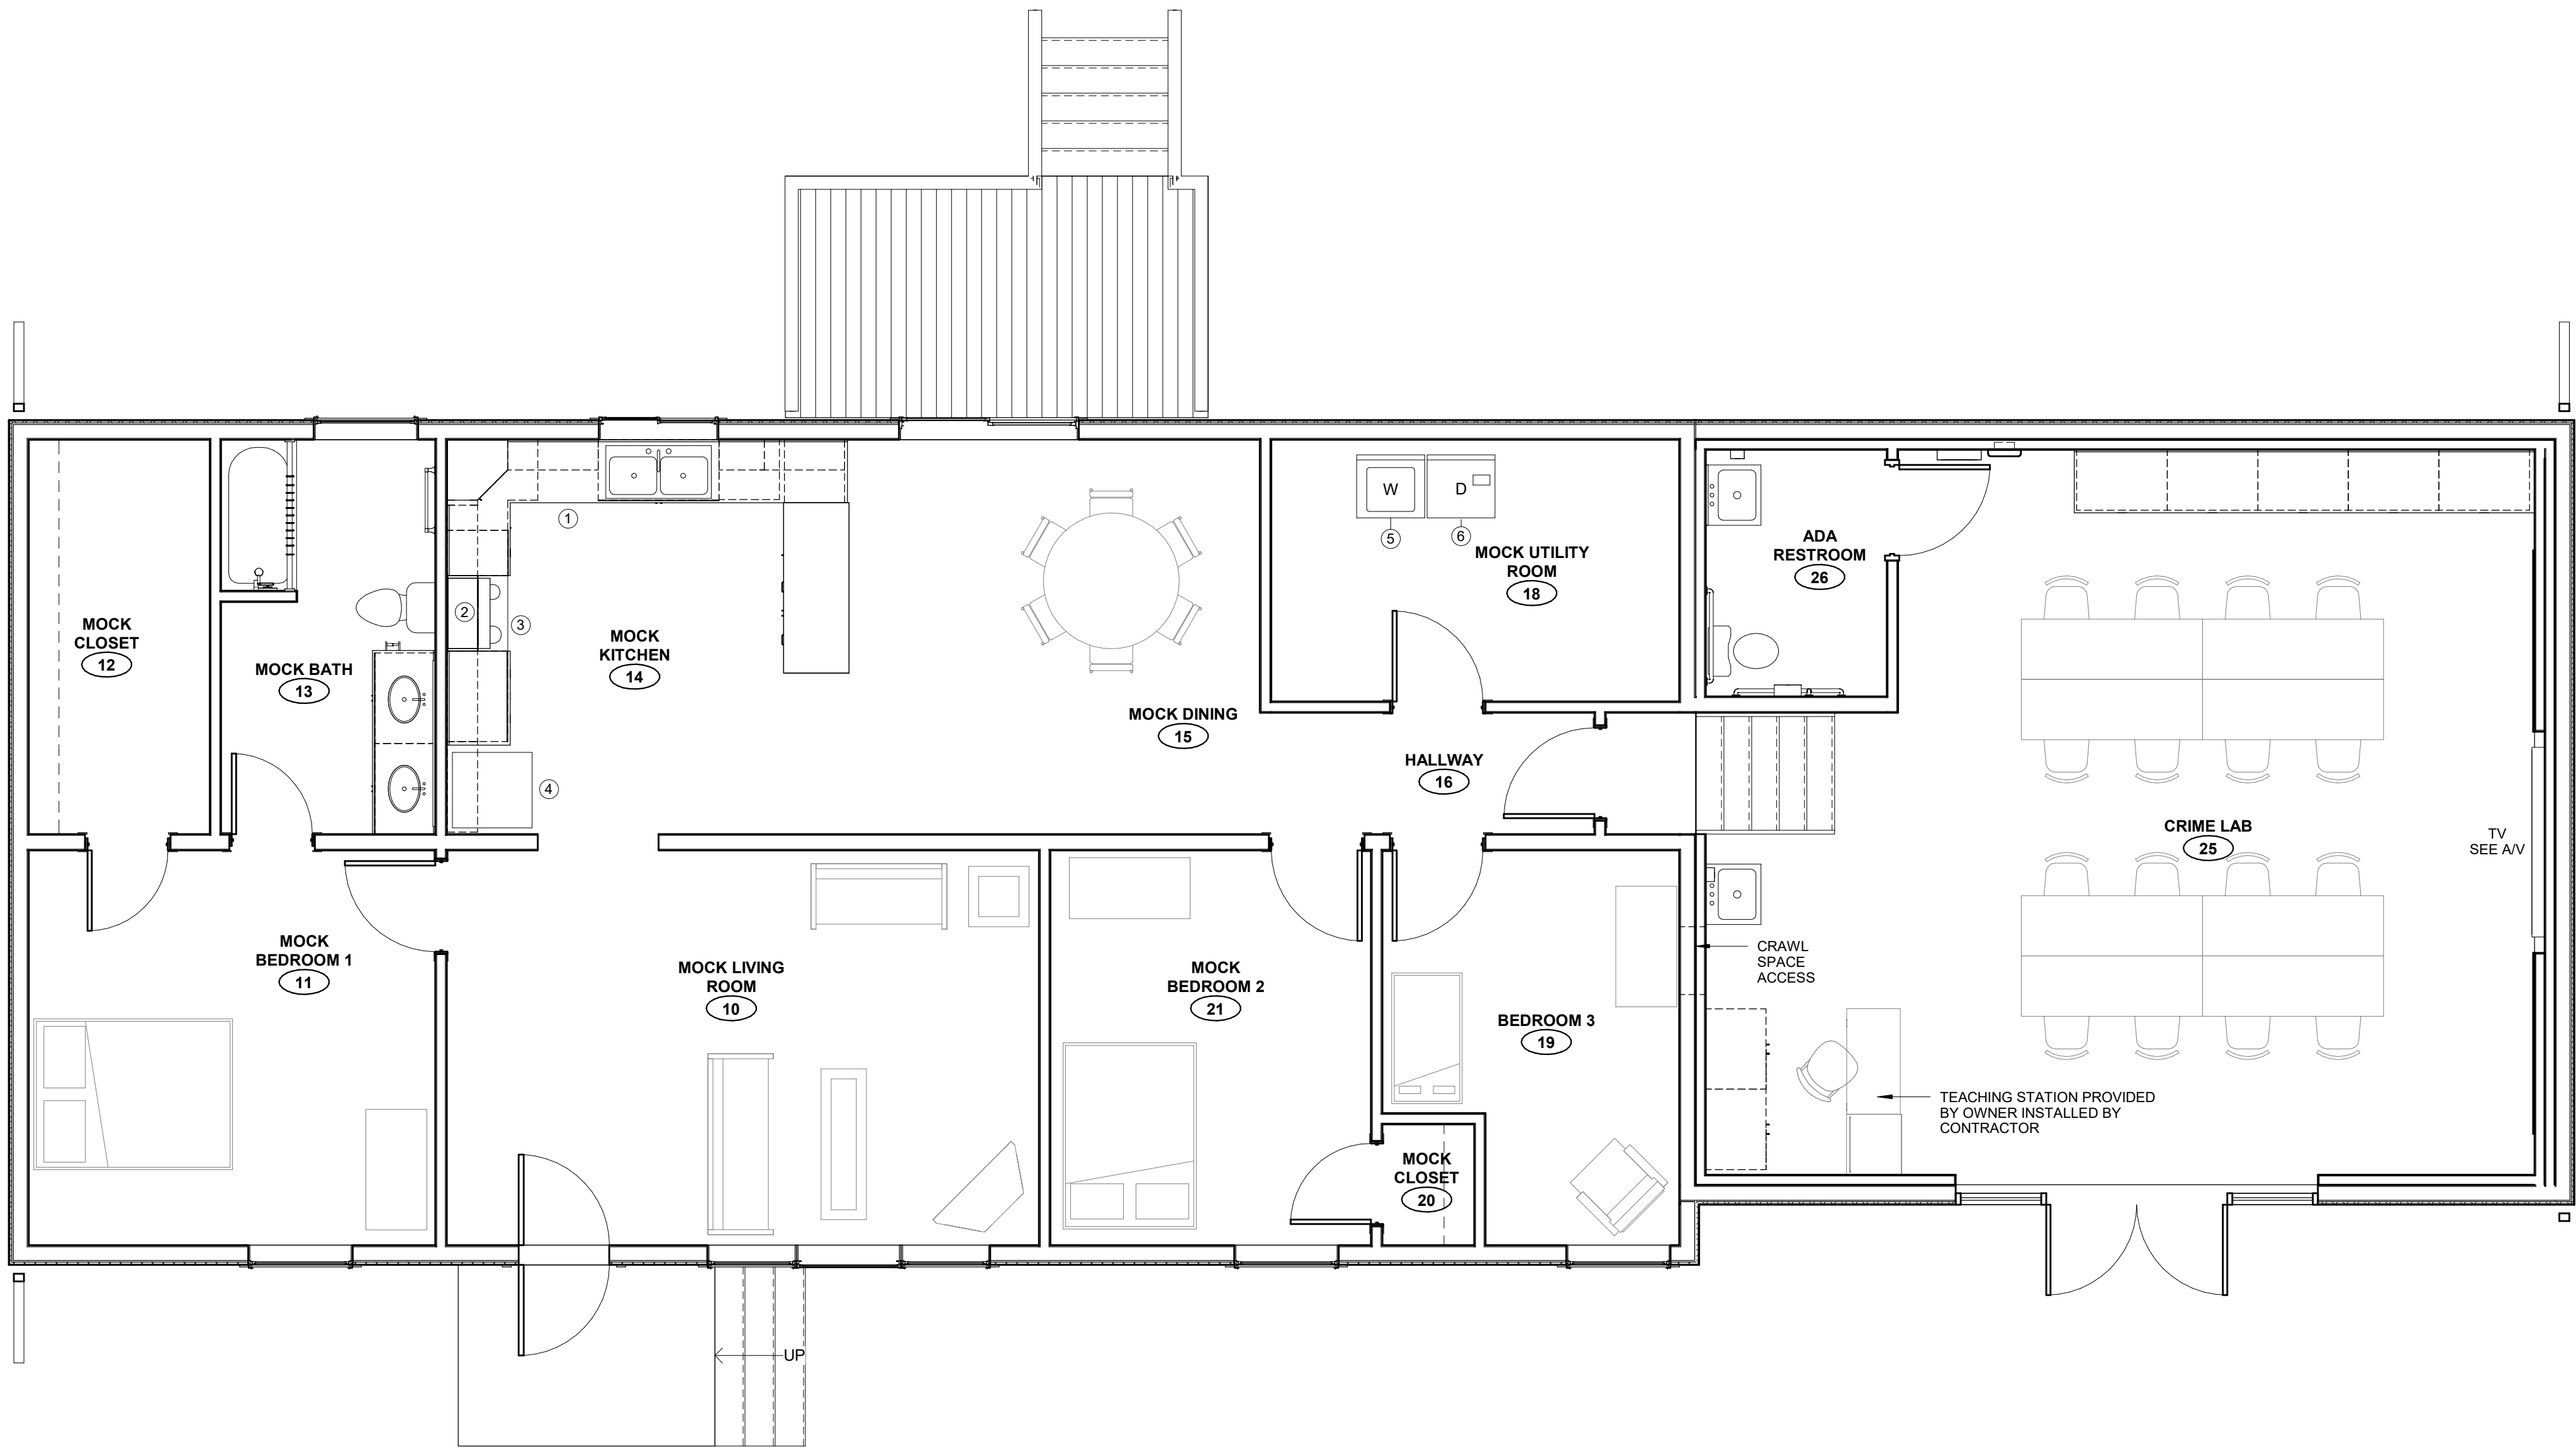

Revision/Issue	Date

Furniture, Fixtures, and
Equipment Floor Plan

Project Number: 2041
Date: January 22, 2021

Copyright © 2021
WILKINS Architecture | Design | Planning L.L.C.

Sheet Number: